


ELECTRICAL LEGEND							
⊙	RECESSED HI-HAT	⊙	INTERCOM BASE STATION	⊙	GARAGE PHOTO SWITCH	⊙	GARAGE DOOR SENSOR BEAM
⊙	MINI RECESSED HI-HAT	⊙	INTERCOM SPEAKER	⊙	⊙	⊙	DIRECT WIRED MOTOR
⊙	HALOGEN LIGHT FIXTURE	⊙	DOOR BELL	⊙	⊙	⊙	DISCONNECT SWITCH
⊙	GLOBE LIGHT	⊙	CHIME BOX	⊙	⊙	⊙	PUSH BUTTON
⊙	FLUORESCENT LIGHT	⊙	JUNCTION BOX	⊙	⊙	⊙	FLOOR OUTLET
⊙	VAPOR PROOF RECESSED LIGHT FIXTURE	⊙	THERMOSTAT/HUMIDISTAT	⊙	⊙	⊙	220V RECEPTACLE
⊙	WALL MOUNTED FIXTURE	⊙	CABLE TELEVISION LOCATION	⊙	⊙	⊙	SWITCH
⊙	KEYLESS LIGHT FIXTURE	⊙	PHONE JACK	⊙	⊙	⊙	3 WAY SWITCH
⊙	TRACK LIGHT	⊙	EXHAUST FAN	⊙	⊙	⊙	4 WAY SWITCH
⊙	FLOOD LIGHT	⊙	OUTLET FOR GARAGE DOOR OPENER	⊙	⊙	⊙	120V RECEPTACLE
⊙	PIER MOUNTED LIGHT FIXTURE	⊙	CEILING FAN	⊙	⊙	⊙	HALF HOT RECEPTACLE
⊙	PENDANT LIGHT FIXTURE	⊙	HARD WIRED SMOKE ALARM	⊙	⊙	⊙	120V G.F.I.
							WEATHER PROOF G.F.I.
							DEDICATED CIRCUIT 20V

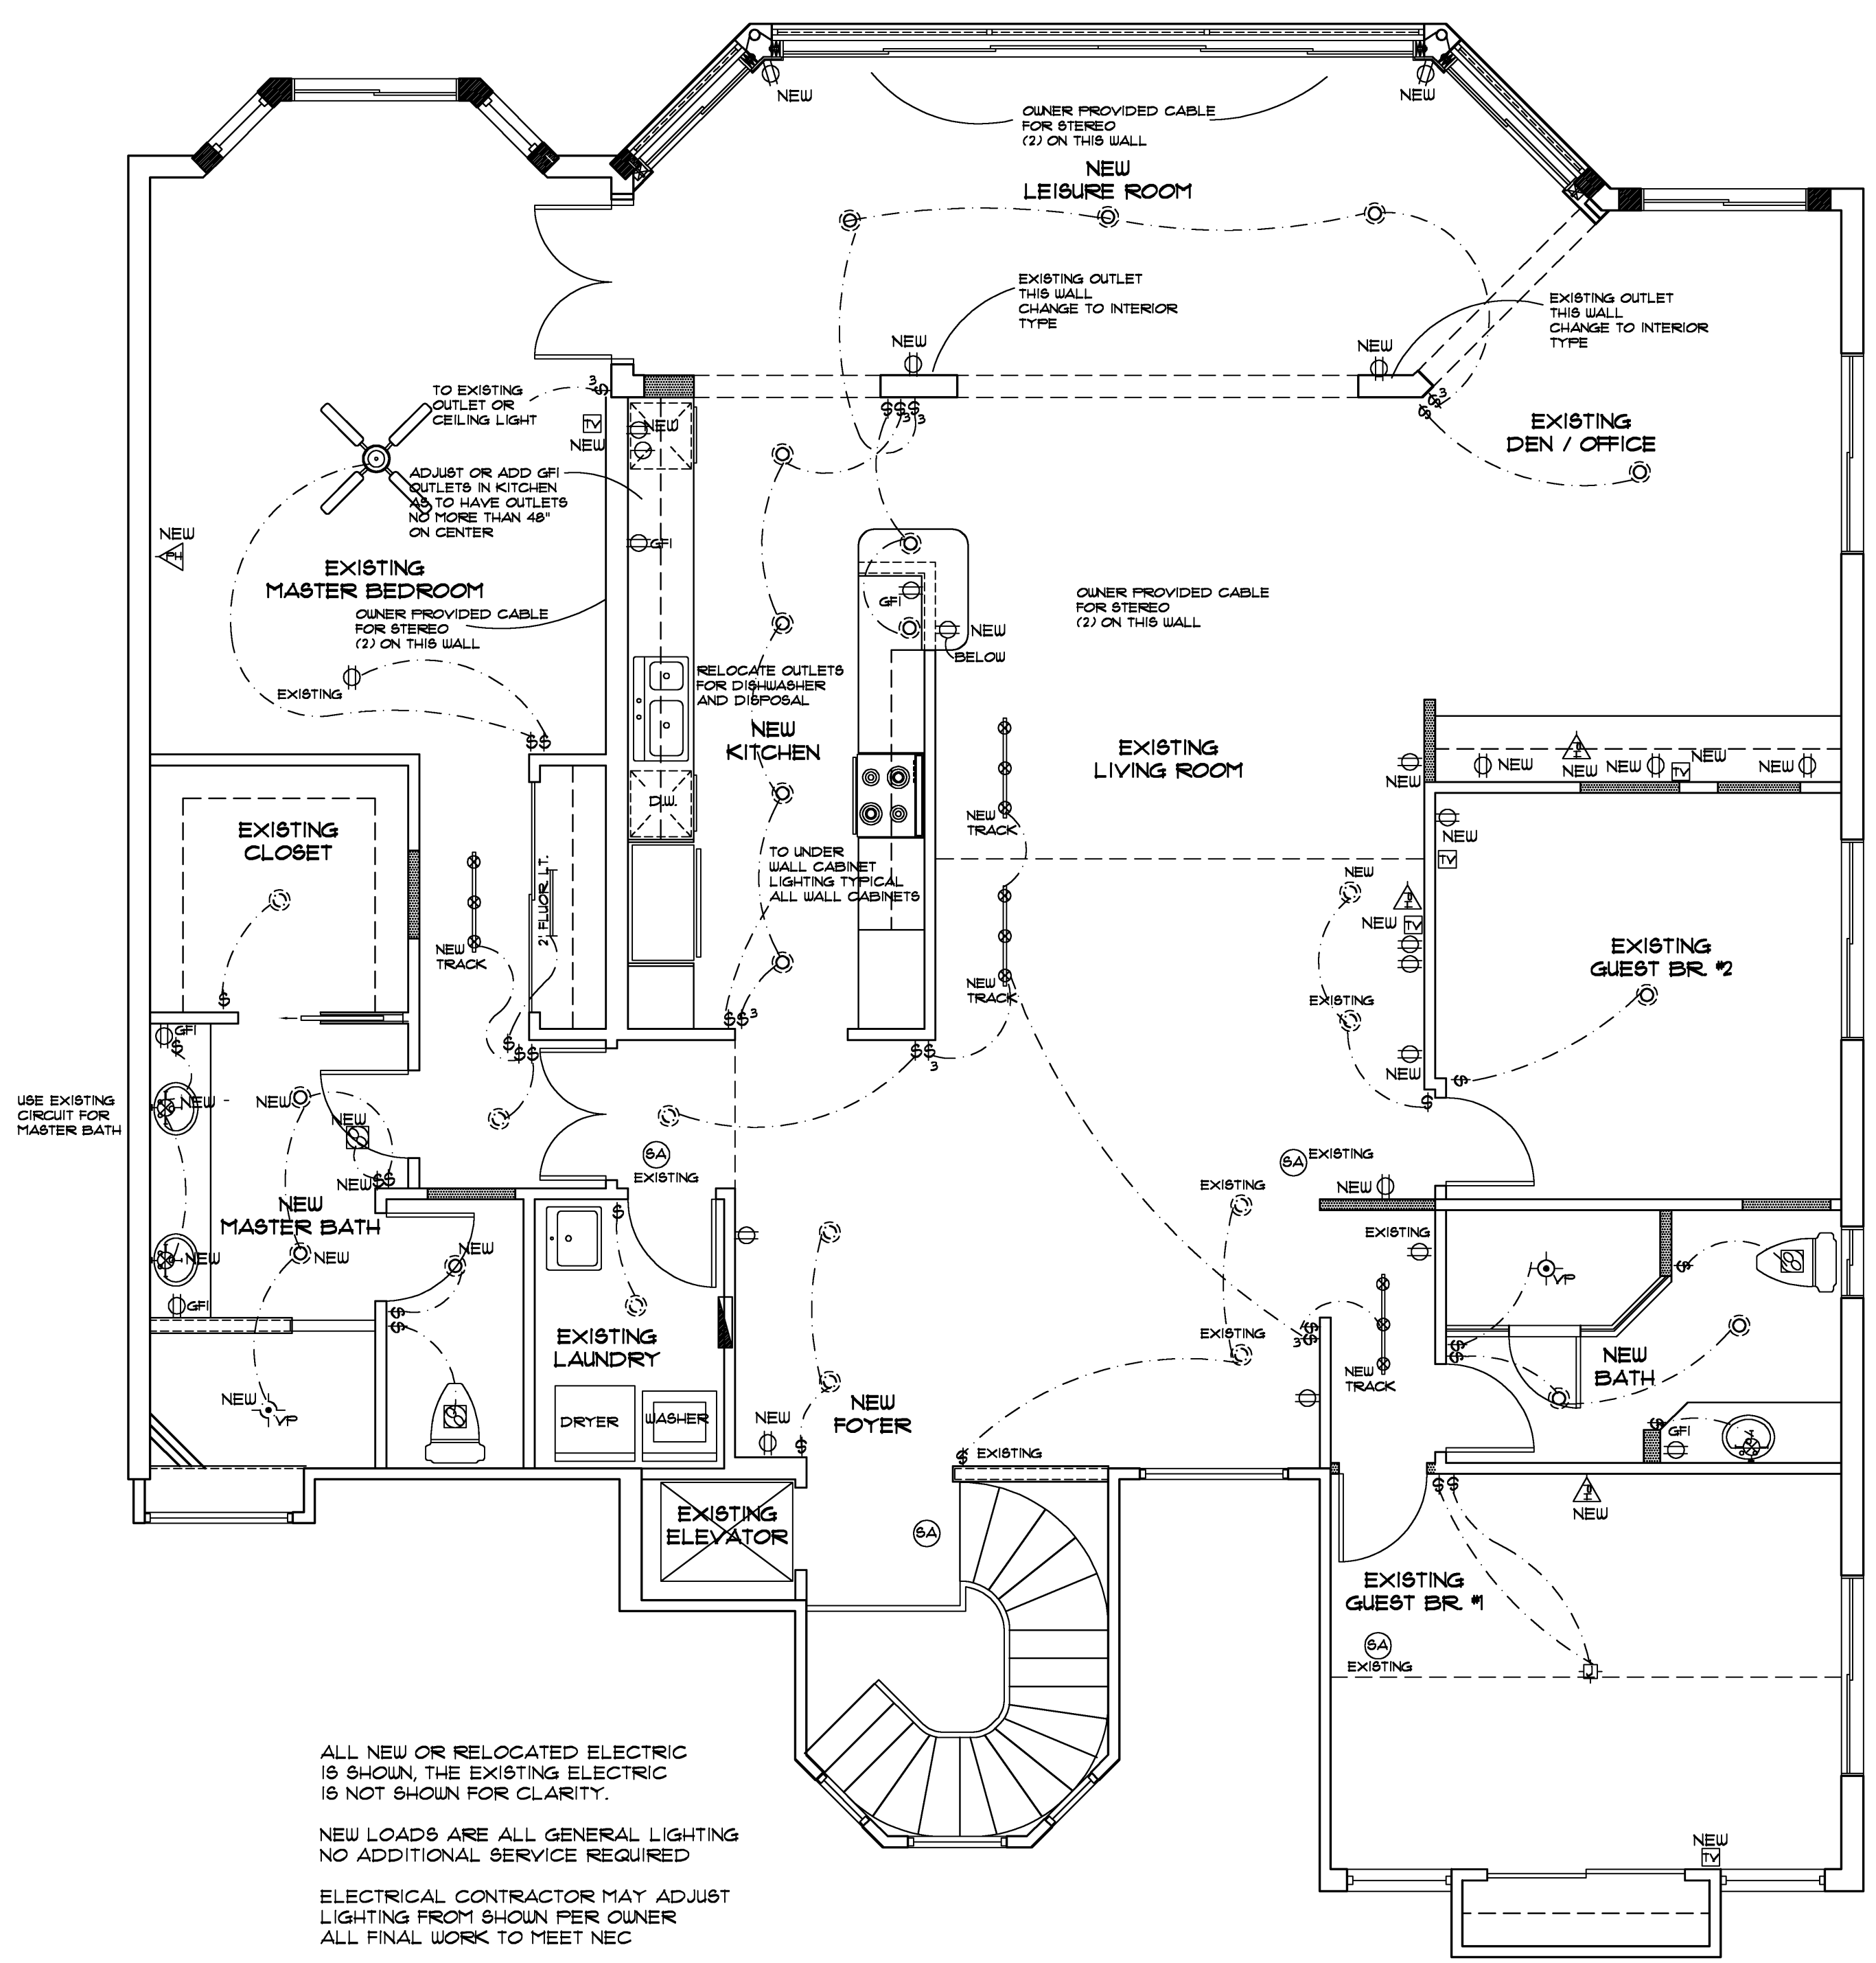

ALL NEW OR RELOCATED ELECTRIC IS SHOWN, THE EXISTING ELECTRIC IS NOT SHOWN FOR CLARITY.

NEW LOADS ARE ALL GENERAL LIGHTING NO ADDITIONAL SERVICE REQUIRED

ELECTRICAL CONTRACTOR MAY ADJUST LIGHTING FROM SHOWN PER OWNER ALL FINAL WORK TO MEET NEC

NEW ELECTRIC PLAN

SCALE 1/4"=1'-0"

A REMODEL PROJECT FOR:
FRANK MARCO
184 EAGLE DRIVE
ADMIRALS COVE
JUPITER, FLORIDA

Consulting Architect
Stephan A. Yeckes Architect, PA
772 U.S. Highway One North Palm Beach, Florida 33408
(561) 626-0402

MP Design, Inc.
P/E (561) 783-4883
CUSTOM HOME DESIGNER
1709 86th ROAD NORTH
WEST PALM BEACH, FL 33412

DRAWN
CHECKED
DATE 05/21/08
SCALE AS SHOWN
JOB NO.
SHEET 3
OF SHEETS